


PHASE 1 PHASE 2

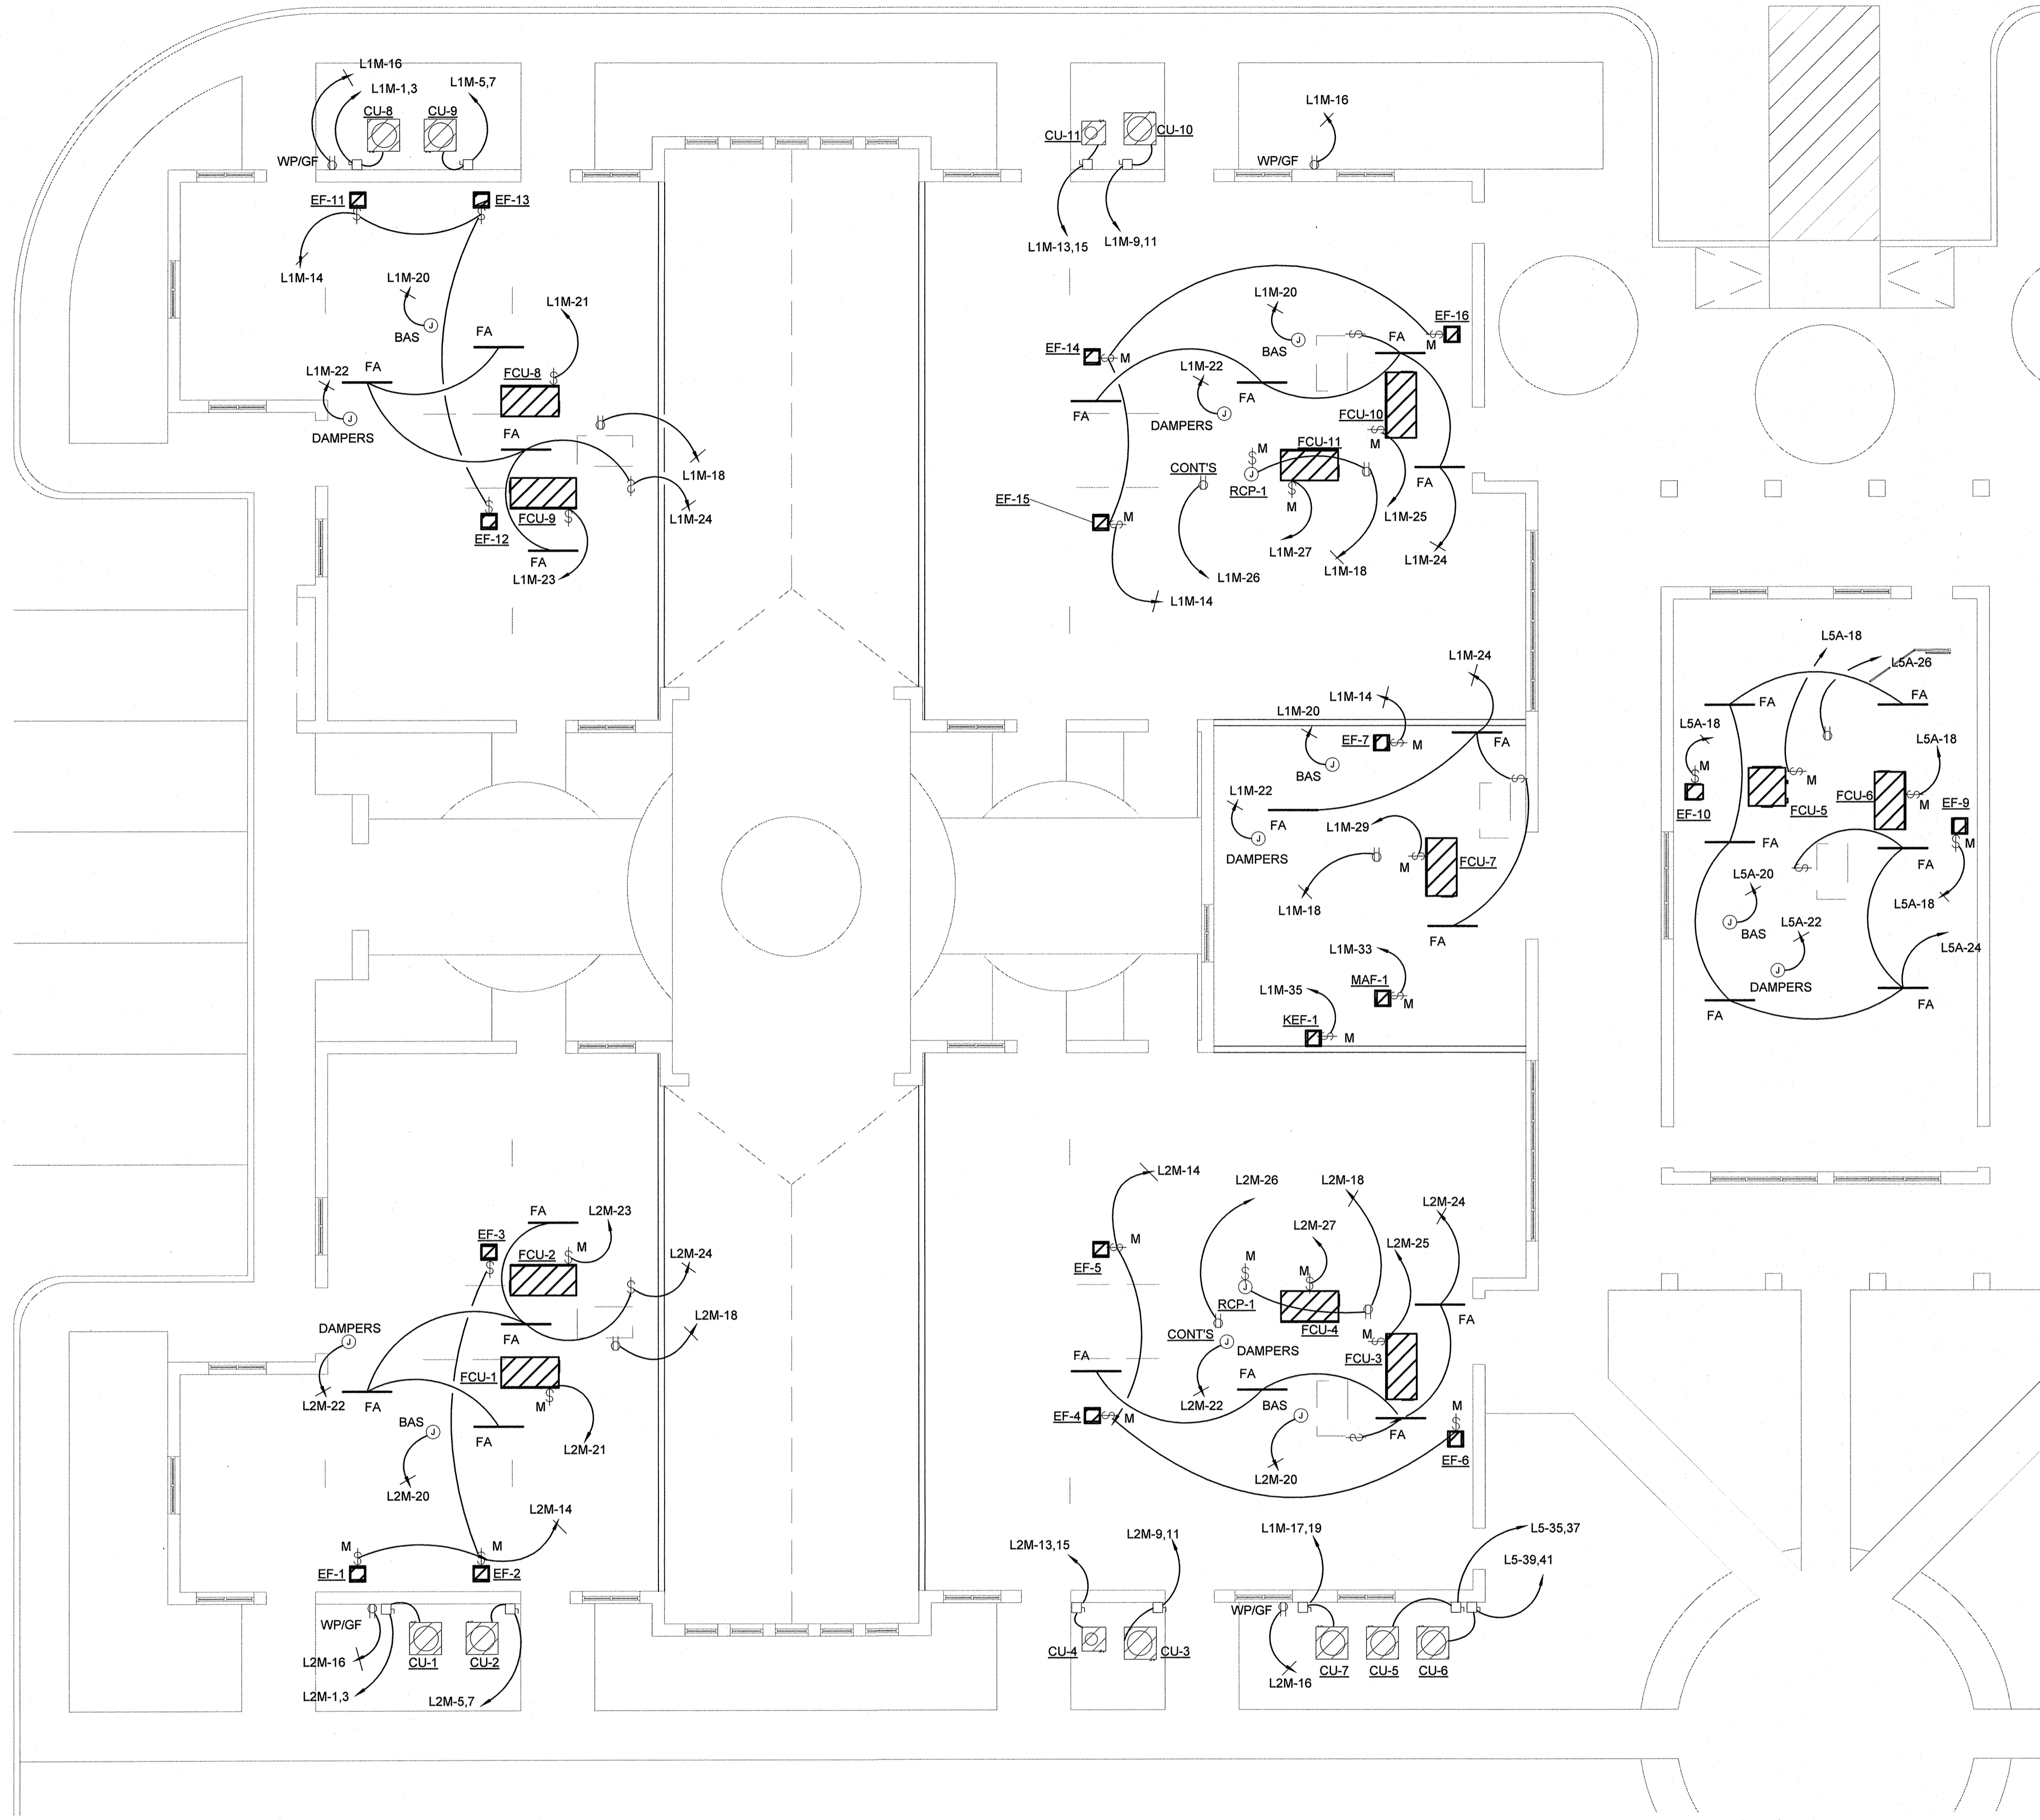


1 ELECTRICAL POWER AND LIGHTING PLAN - AREA A - MEZZANINE LEVEL
1/8" = 1'-0"

REFER TO ARCHITECTURAL DRAWINGS FOR ADDITIONAL PHASING INFORMATION.

OPTIMUM CARE
SUGAR LAND, TEXAS



Revision Schedule		
#	Date	Description

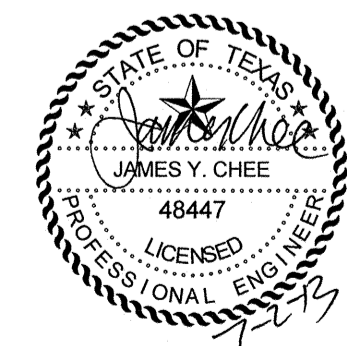

REDDING LINDEN BARR
CONSULTING ENGINEERS
801 TRAVIS, SUITE 2000
HOUSTON, TEXAS 77002
PH: 713.237.9800
FAX: 713.237.9801
TEXAS REGISTERED ENGINEERING FIRM F-3113

Project No.
ELECTRICAL PLAN - AREA A - MEZZ LEVEL
Sheet No.

E1.03

File Name: M:\Radian Architecture\12523.00 Optimum Care - Sugar Land\Elect\12523.00 REVIT ELECTRICAL.rvt
User: Author
Date/Time: 7/2/2013 3:21:59 PM