



File Name: C:\DMS\Revit_Projects\Optimum Personal Care-Phase 2-MECH_derek.weber.rvt
 User: Author
 Date/Time: 2/13/2019 1:31:25 PM

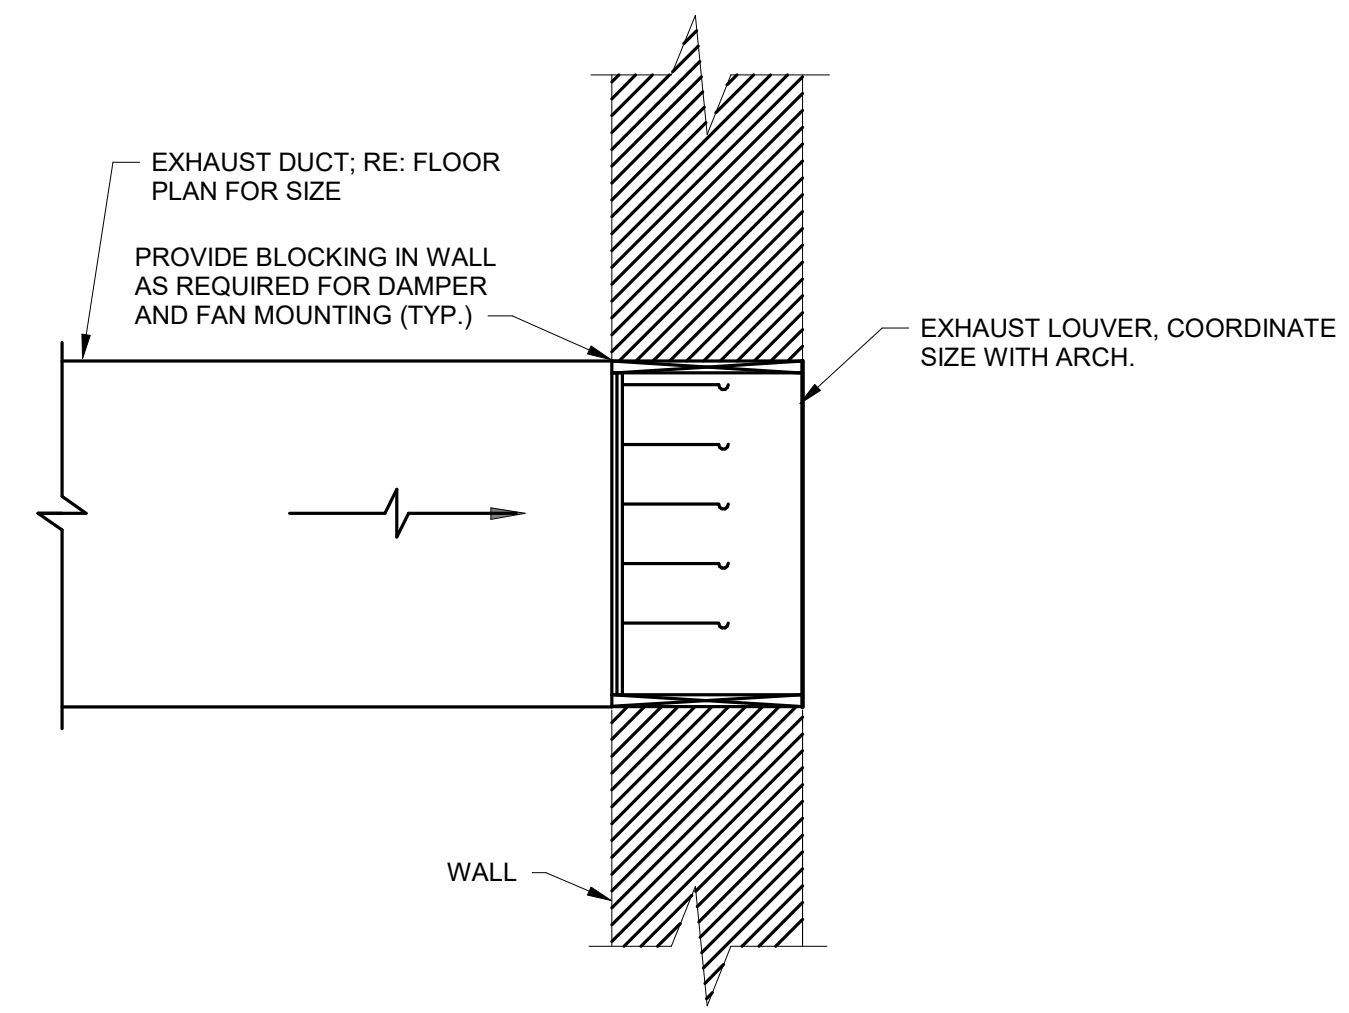


1 EXHAUST SIDEWALL TERMINATION DETAIL
 NOT TO SCALE

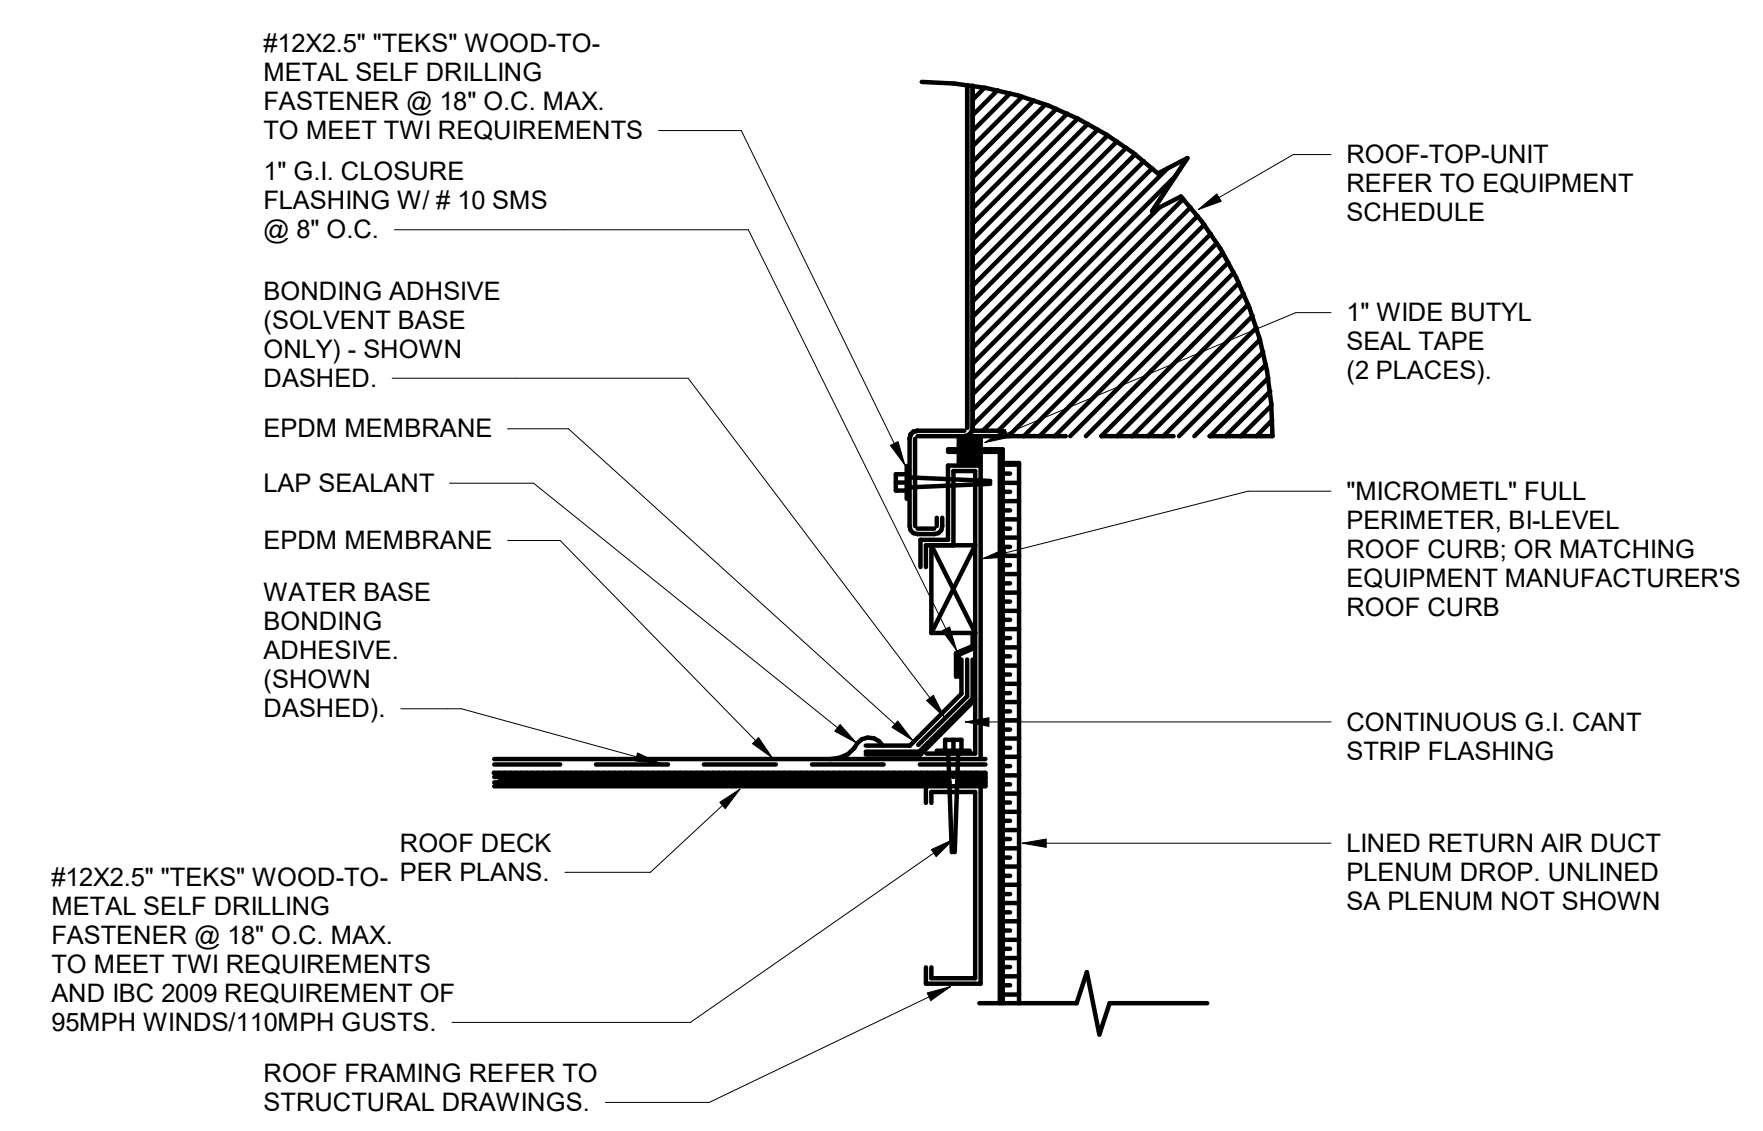

NOTE: COORDINATE RTU INSTALLATION WITH ROOF CONTRACTOR & GC. FIELD VERIFY LOCATION OF STRUCTURAL MEMBERS FOR RTU PLACEMENT PRIOR TO INSTALLATION. PROVIDE CROSS BRACING SUPPORT MEMBERS, WHERE REQUIRED, TO ENSURE ROOF CURB CAN BE SECURED TO STRUCTURE TO MEET TEXAS WINDSTORM INSURANCE (TWI) REQUIREMENTS AND IBC 2009 REQUIREMENT OF 95MPH WINDS/110MPH GUSTS. COORDINATE FINAL INSTALLATION WITH STRUCTURAL ENGINEER.

2 EQUIPMENT ON ROOF CURB DETAIL
 NOT TO SCALE

OPTIMUM CARE
SUGAR LAND, TEXAS

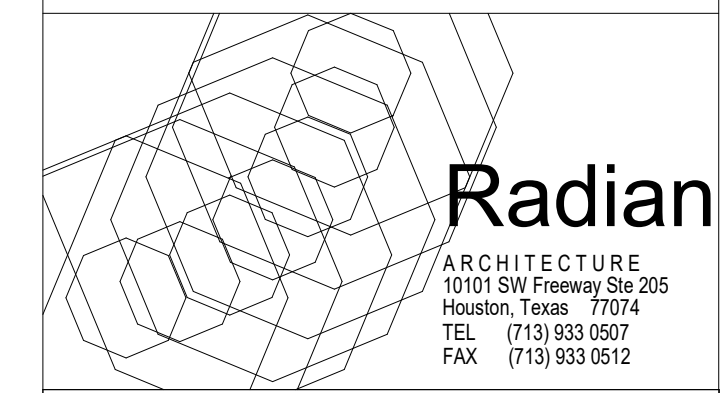

Revision Schedule		
#	Date	Description
10-26-18		PERMIT, PRICING, AND CONSTRUCTION
02-14-19		City Comments

Project No.

MECHANICAL DETAILS

Sheet No.

M4.2

STATE OF TEXAS
 DEREK R WEBER
 128830
 LICENSED PROFESSIONAL ENGINEER
 2-14-19

KCI
 TECHNOLOGIES
 ENGINEERS
 PLANNERS
 SCIENTISTS
 CONSTRUCTION MANAGERS
 801 TRAVIS, SUITE 2000
 HOUSTON, TX 77002
 PHONE: 713-237-9800
 FAX: 713-237-9801
 Texas Registered Engineering Firm F-10573