


File Name: C:\DMS\Revit_Projects\Optimum Personal Care-Phase 2\PLBG_paul.corley.rvt
 User: paul.corley
 Date/Time: 2/13/2019 1:39:07 PM

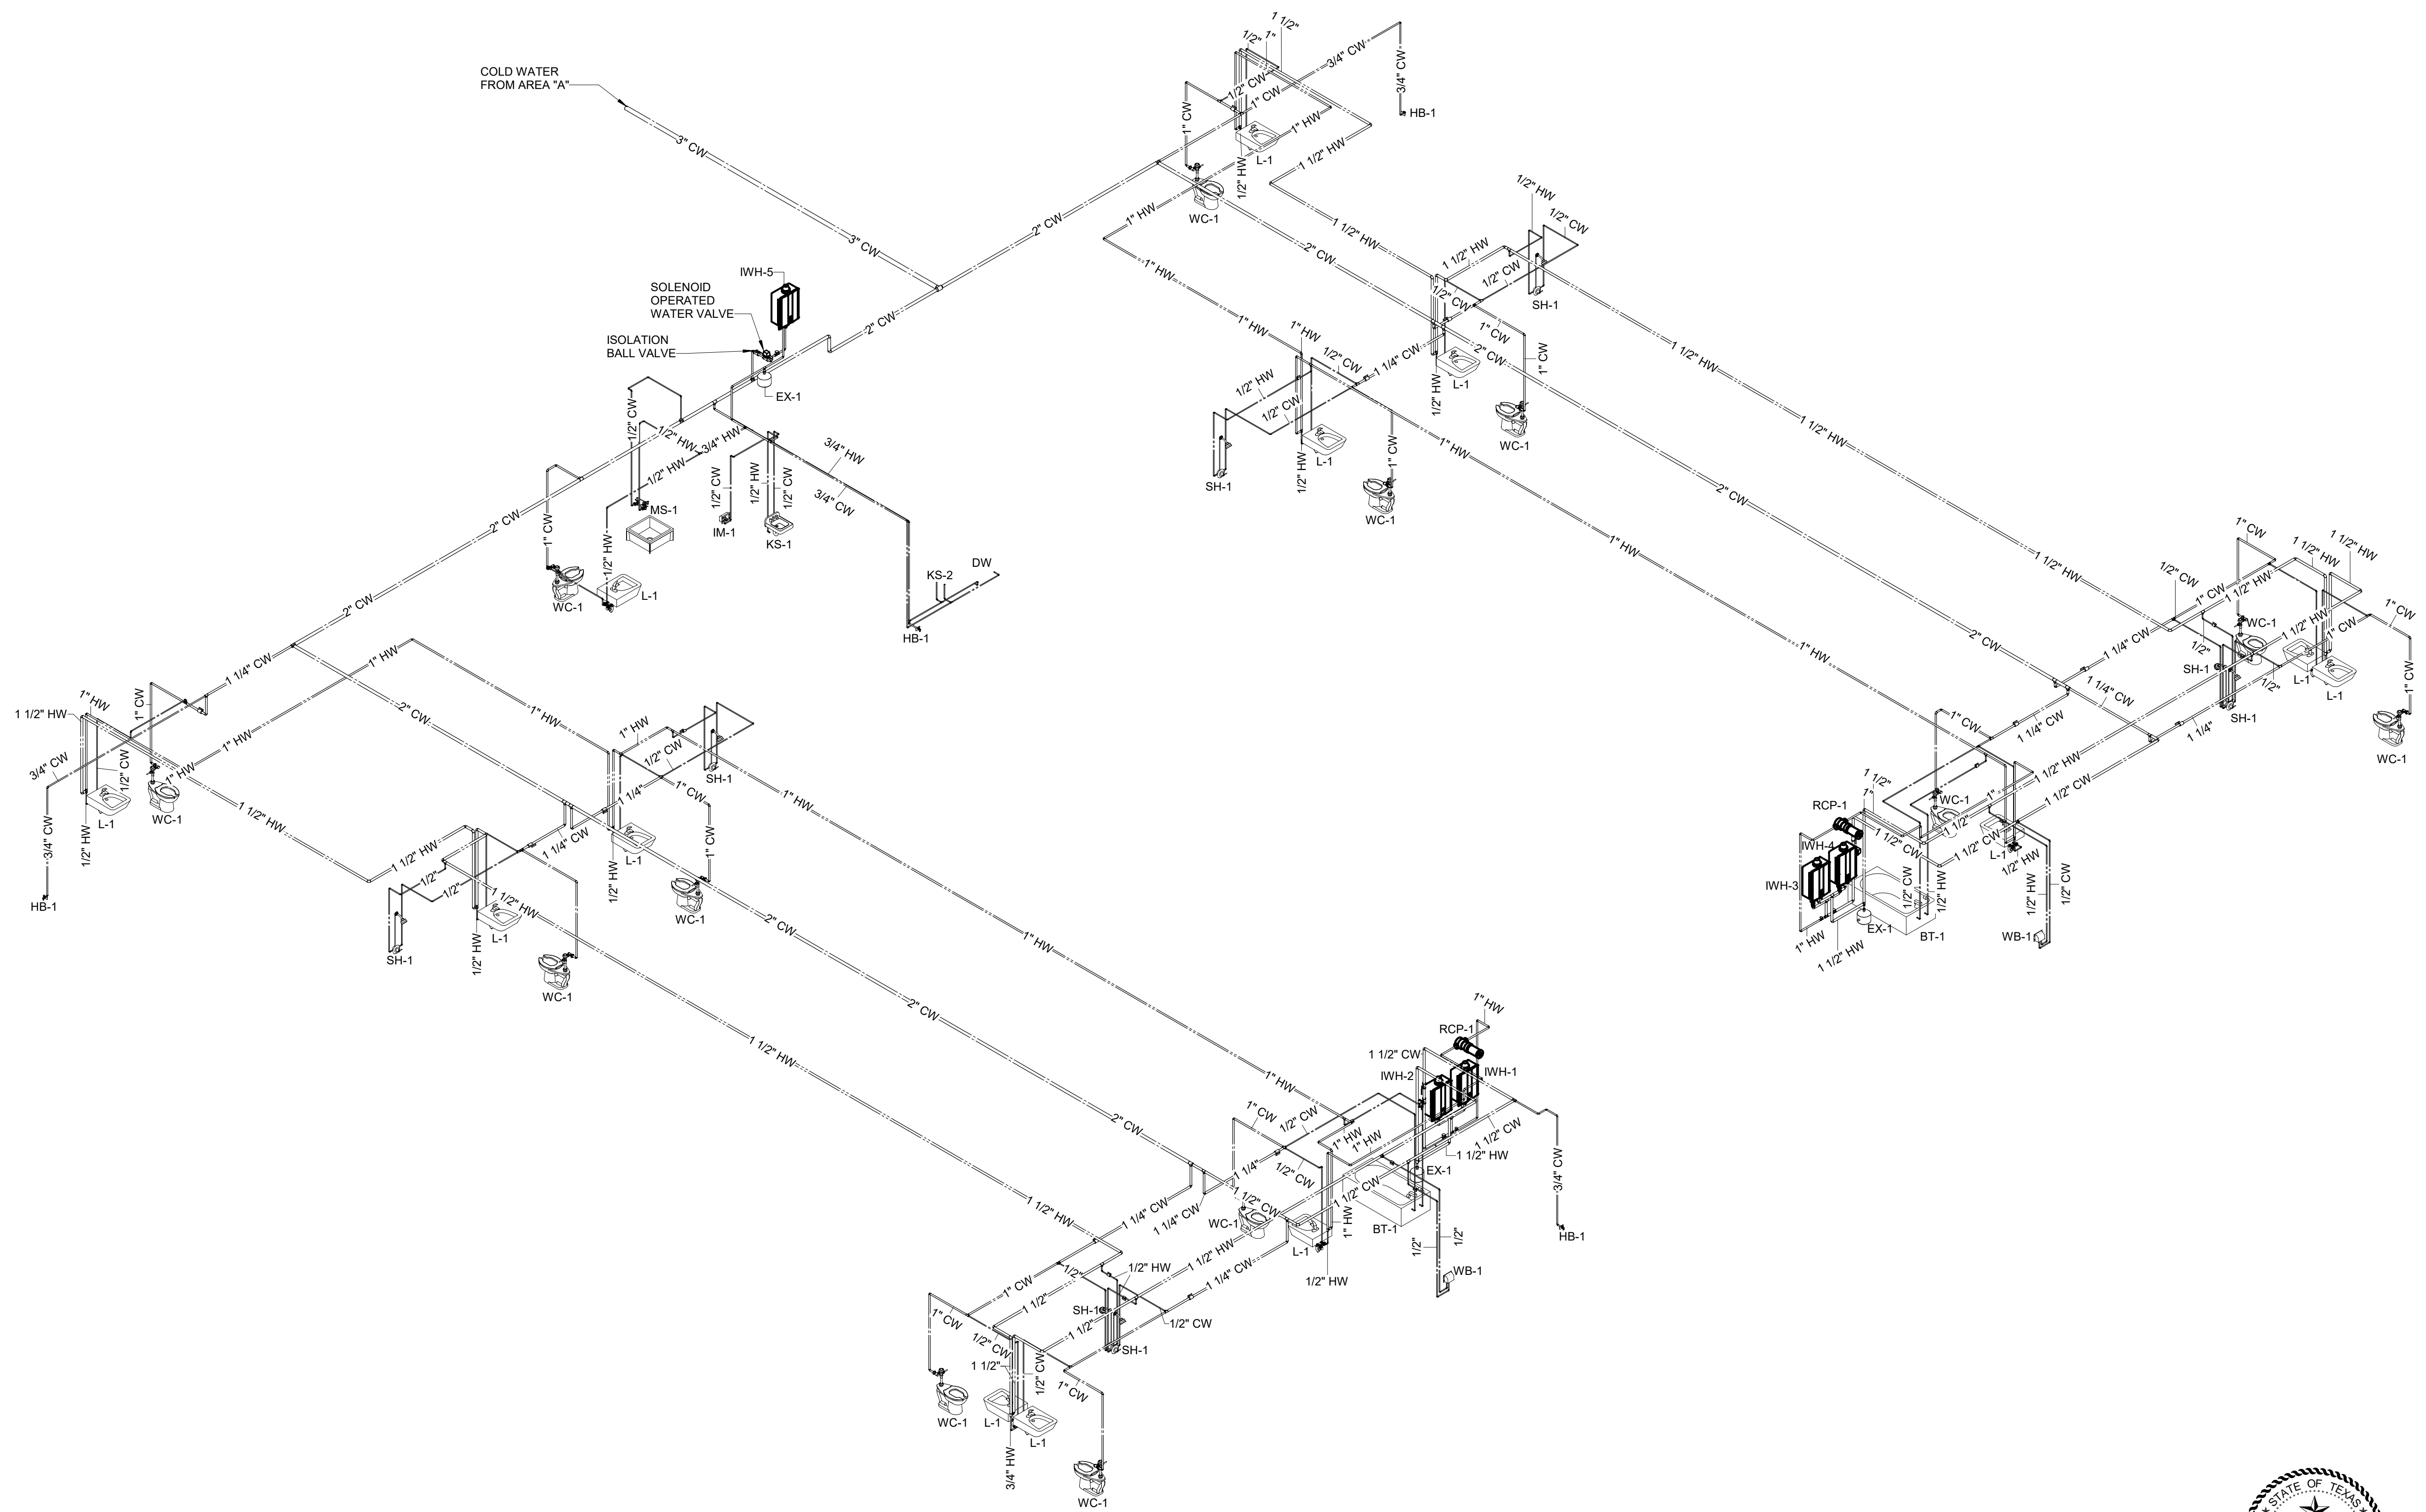

1 PLUMBING RISER DIAGRAM - DOMESTIC WATER - AREA A
 N.T.S.

OPTIMUM CARE
SUGAR LAND, TEXAS



Revision Schedule		
#	Date	Description
10-26-18		PERMIT, PRICING, AND CONSTRUCTION
02-14-19		CITY COMMENTS

Project No.
 PLBG RISER DIAGRAM - DOMESTIC WATER

Sheet No.
P2.02

02-18-19

KCI
 TECHNOLOGIES
 ENGINEERS
 PLANNERS
 SCIENTISTS
 CONSTRUCTION MANAGERS
 801 TRAVIS, SUITE 2000
 HOUSTON, TX 77002
 PHONE: 713-237-9800
 FAX: 713-237-9801
 Texas Registered Engineering Firm F-10573